



Scale: $1\frac{1}{2}" = 1'-0"$

	BY	DATE
MADE	AG	04/2013
TRACED	GS	04/2013
CHECKED	MS	04/2013
SUPERVISED	ALB	04/2013

18"

12"

Pole Cap

2 3/8" O.D. Tube, 3/8" thick (Typ.)

3/8" - 16NC set screw 2 pair at 90°

1/4" Min. thick Tube, length as required (See Note 5)



Pole

LUMINAIRE MOUNTING ASSEMBLY


TYPE V2

Scale: 1 1/2" = 1'-0"


LUMINAIRE MOUNTING ASSEMBLY
TYPE V3
Scale: 1 1/2" = 1'-0"

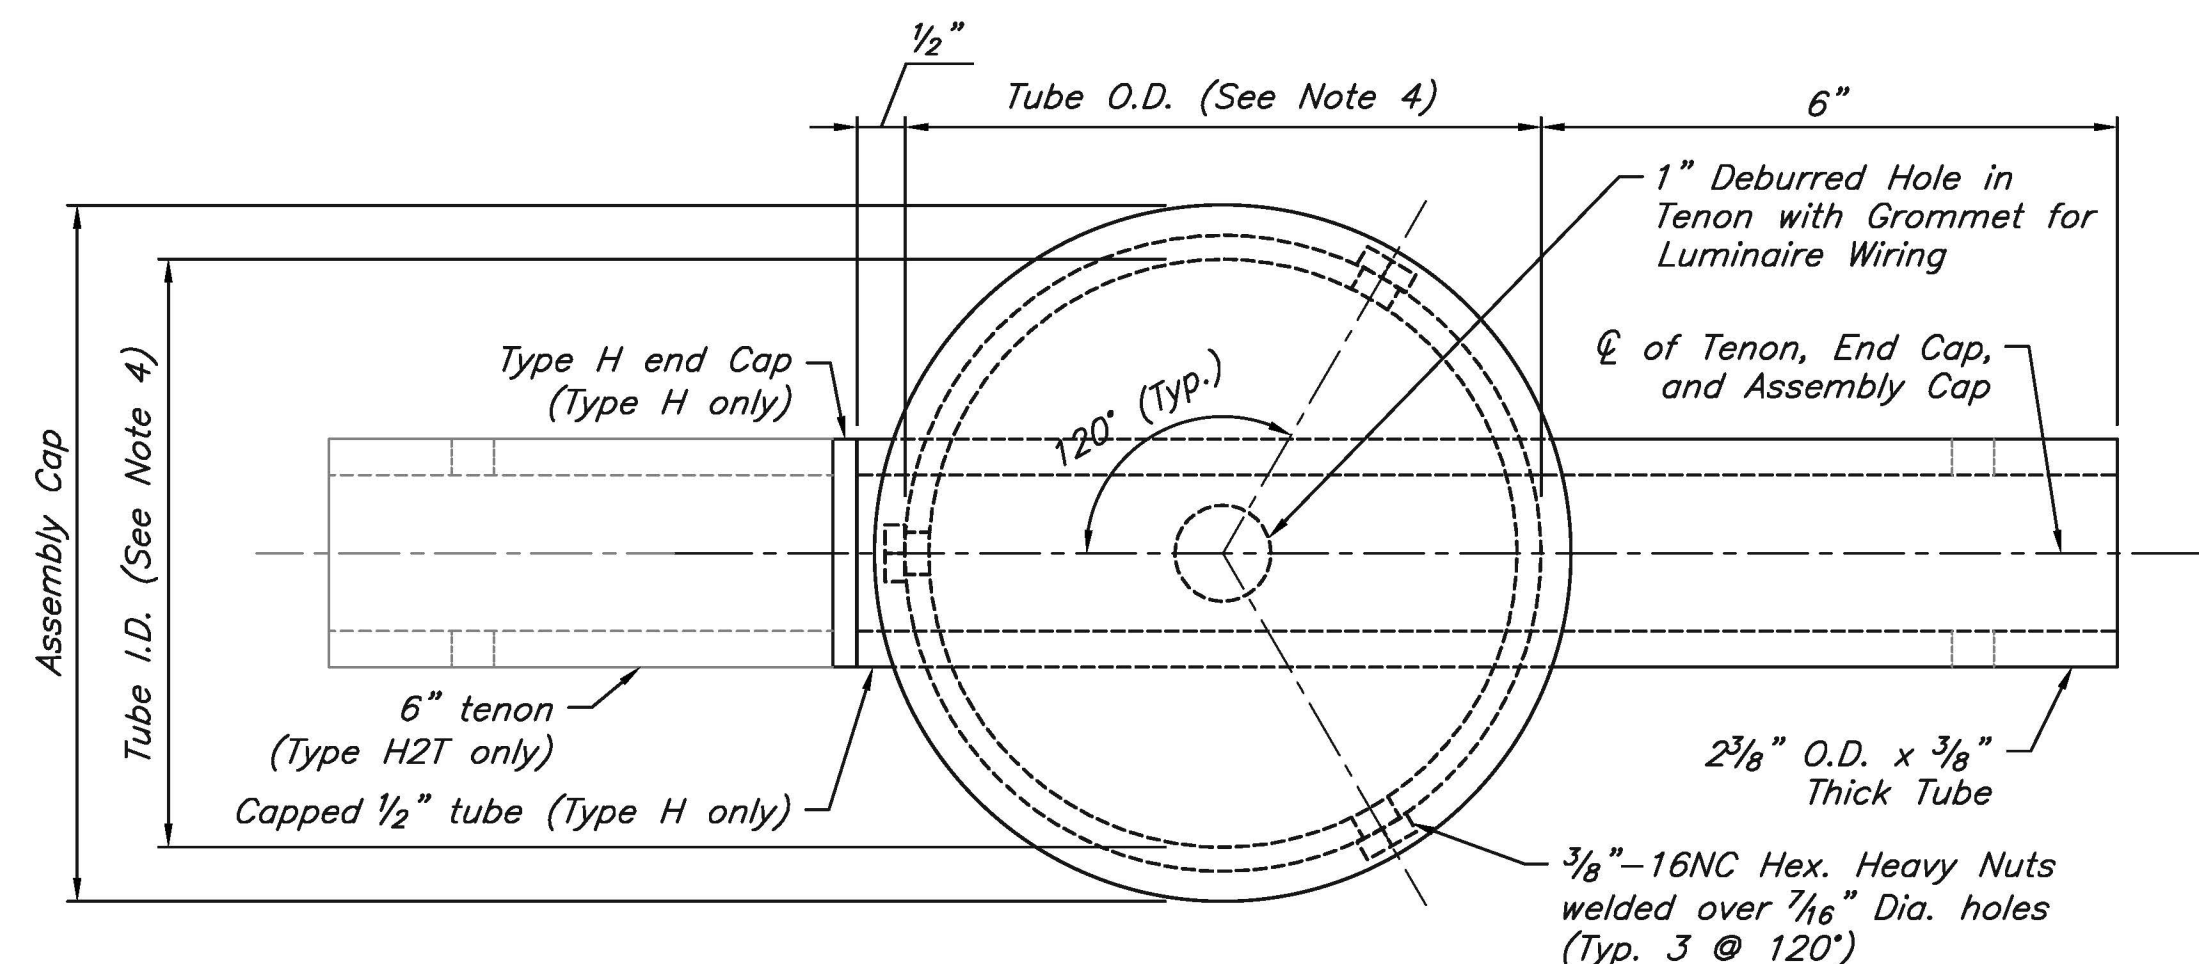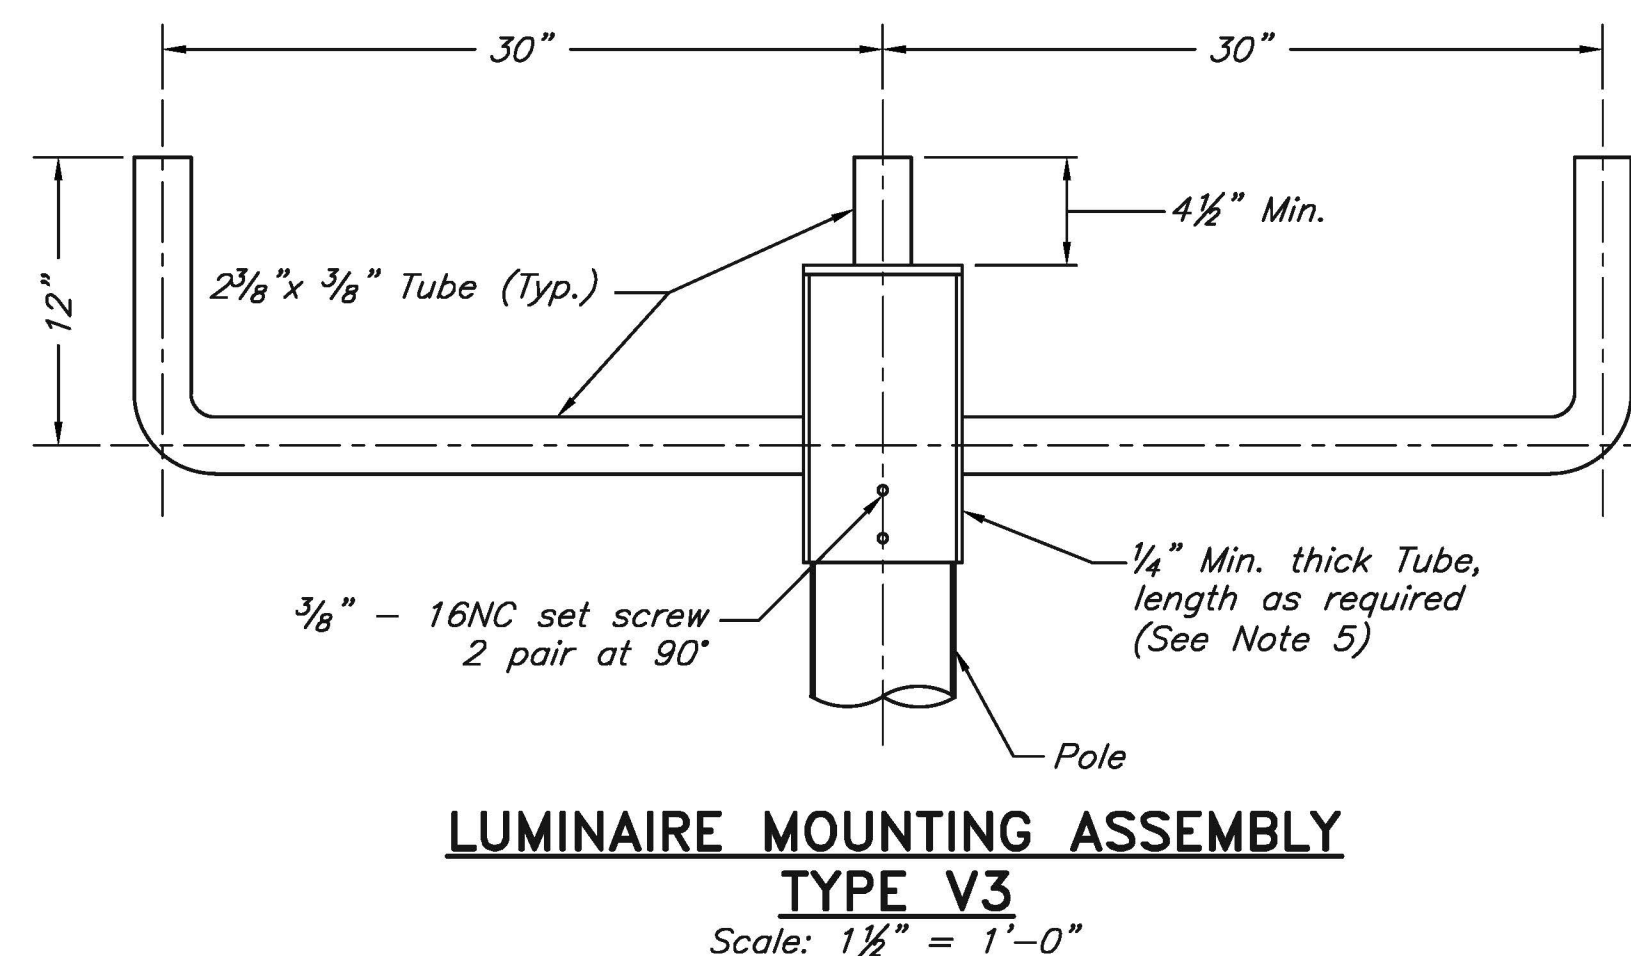


PLAN

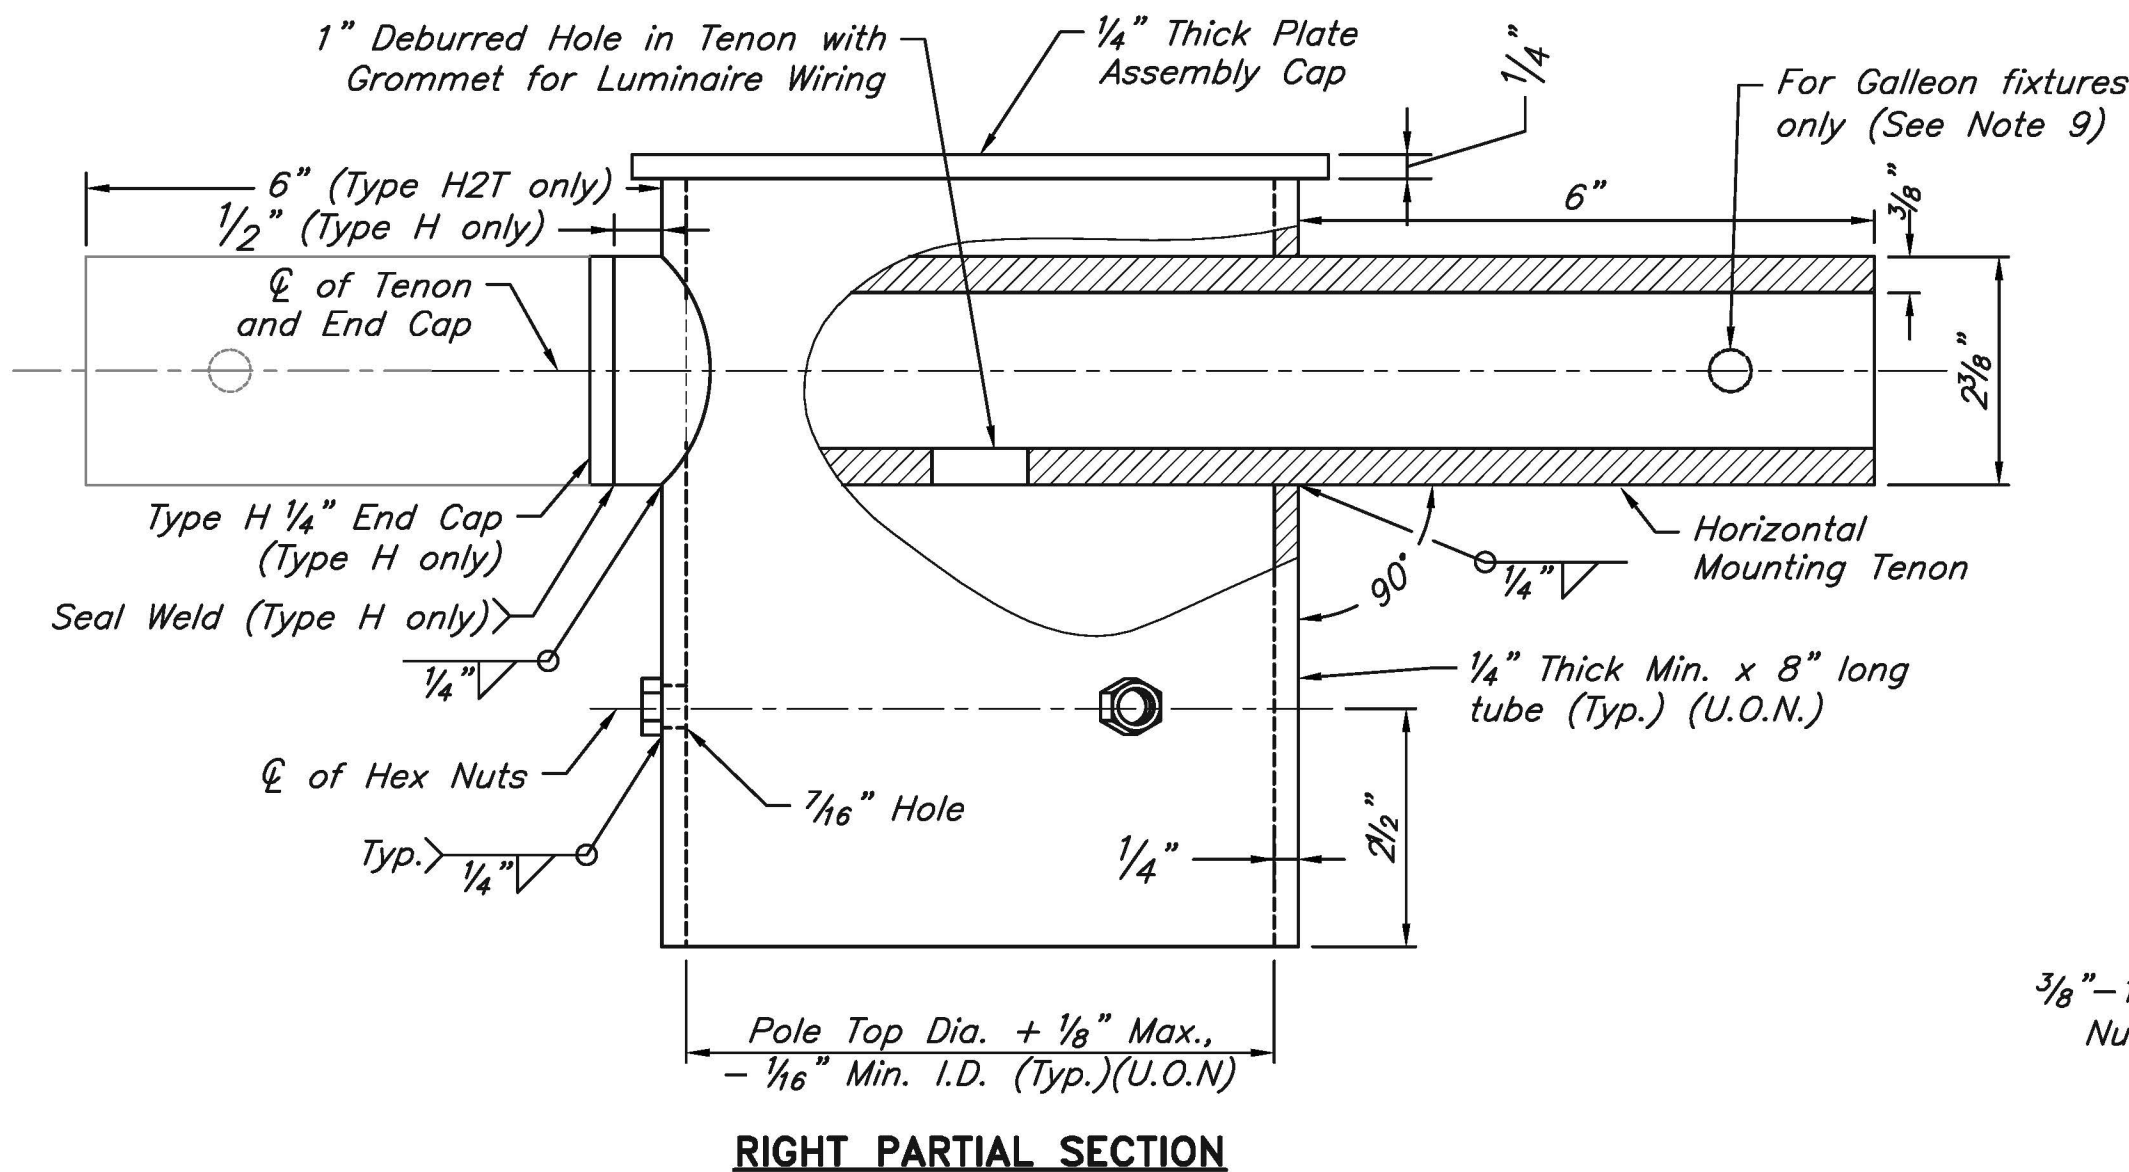

(Type H single tenon, Type H2T twin tenon at 180°)
Scale: 6" = 1'-0"

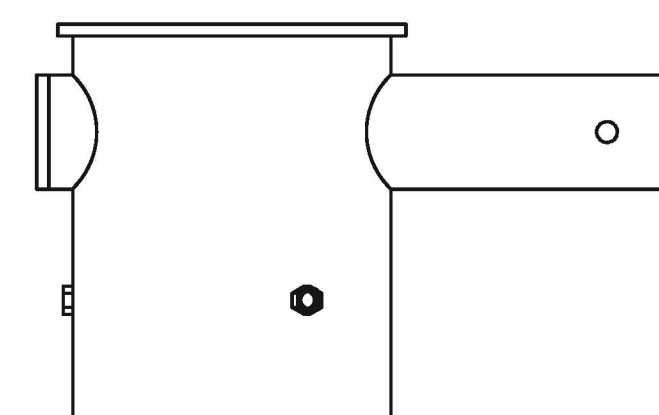


TYPE H – SINGLE TENON

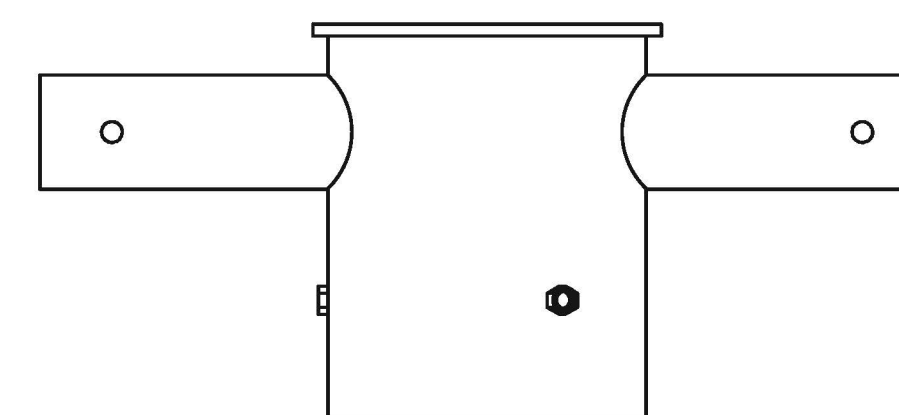

TYPE H2T – TWIN TENON


TYPE H AND H2T ELEVATION VIEW

Scale: 3" = 1'-0"

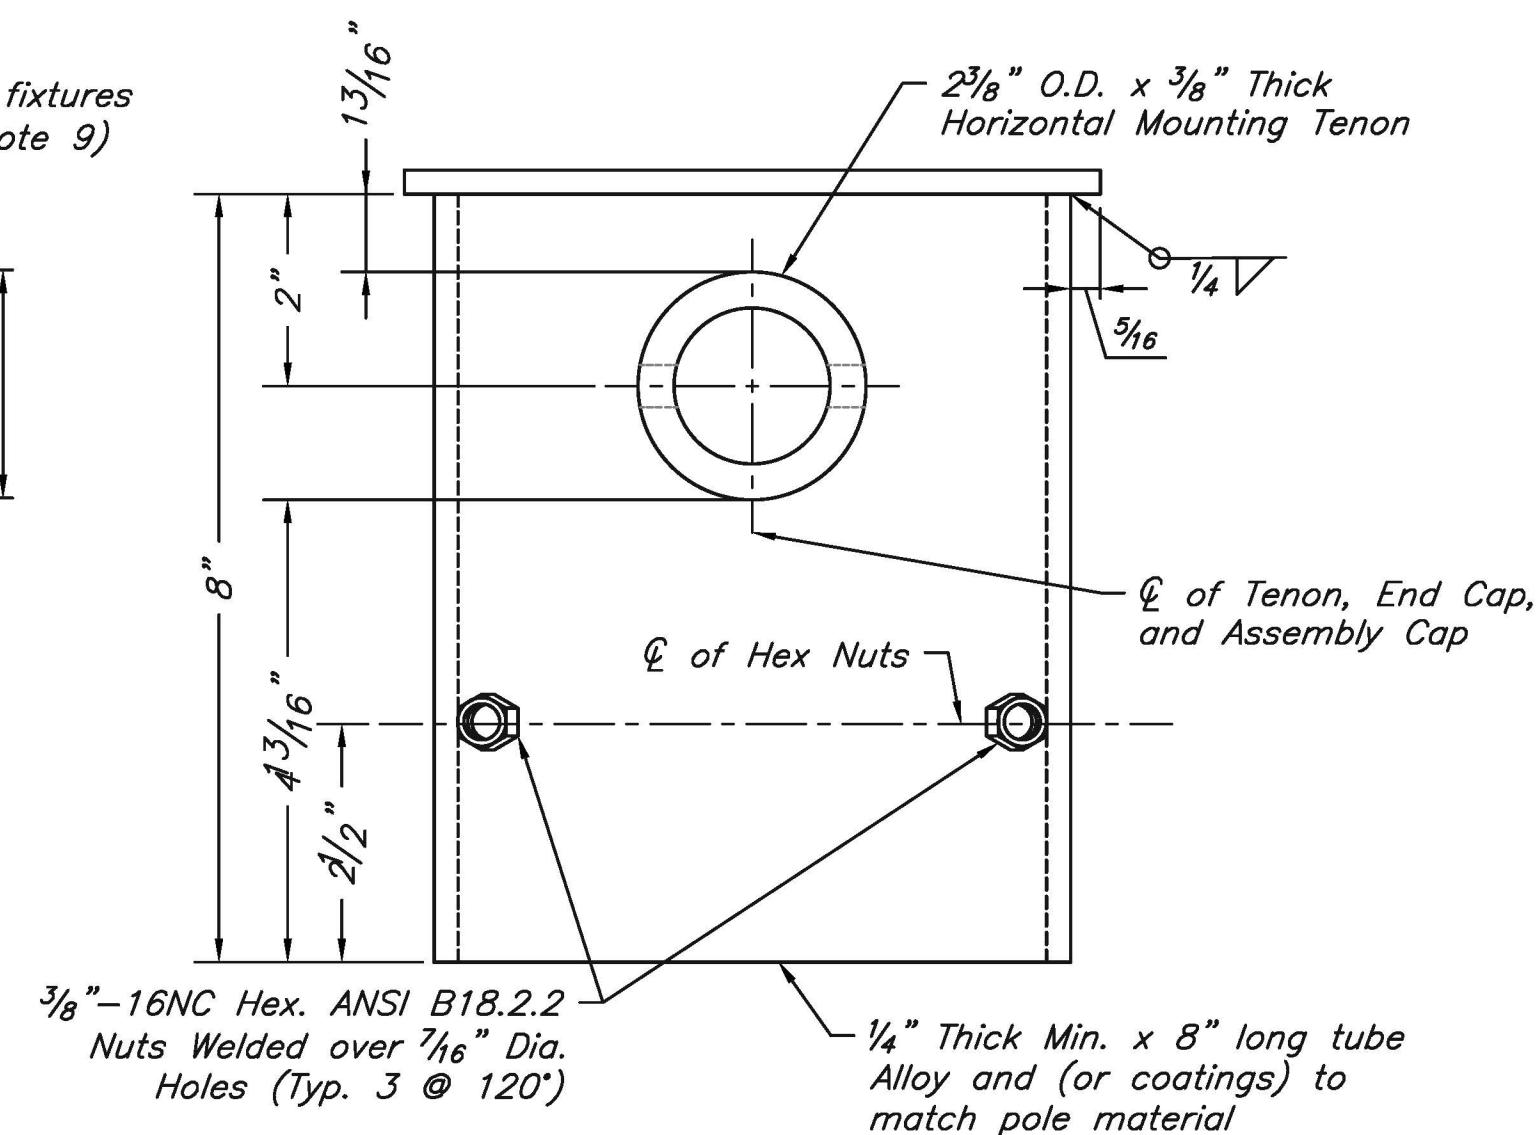

FRONT ELEVATION

<i>If you use this Standard Drawing:</i>	
<i>You also need</i>	<i>E-01,E-03,E-08,E-09</i>
<i>You may need</i>	<i>E-11, E-12, BR-15</i>

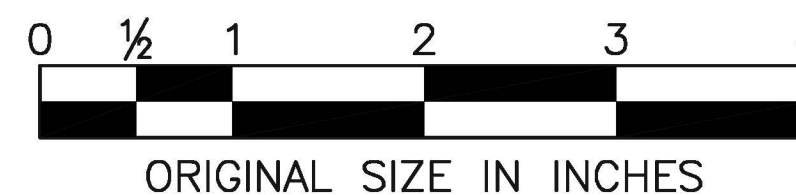

	C	3/2014	CONFORMED DRAWING
APP.	NO.	DATE	REVISION

CONTRACT NO.

NEW JERSEY TURNPIKE AUTHORITY
NEW JERSEY TURNPIKE

POLE-TOP LUMINAIRE MOUNTING ASSEMBLIES

HNTB 9 ENTIN ROAD, SUITE 202,
PARSIPPANY, NJ 07054 - COA# 24GA28000700
ANTHONY L. BARTELLO
Anthony L. Bartello
New Jersey Professional Engineer License No. GE 45842

**STANDARD
DRAWING
E-03A**

SHEET NO.

OF